


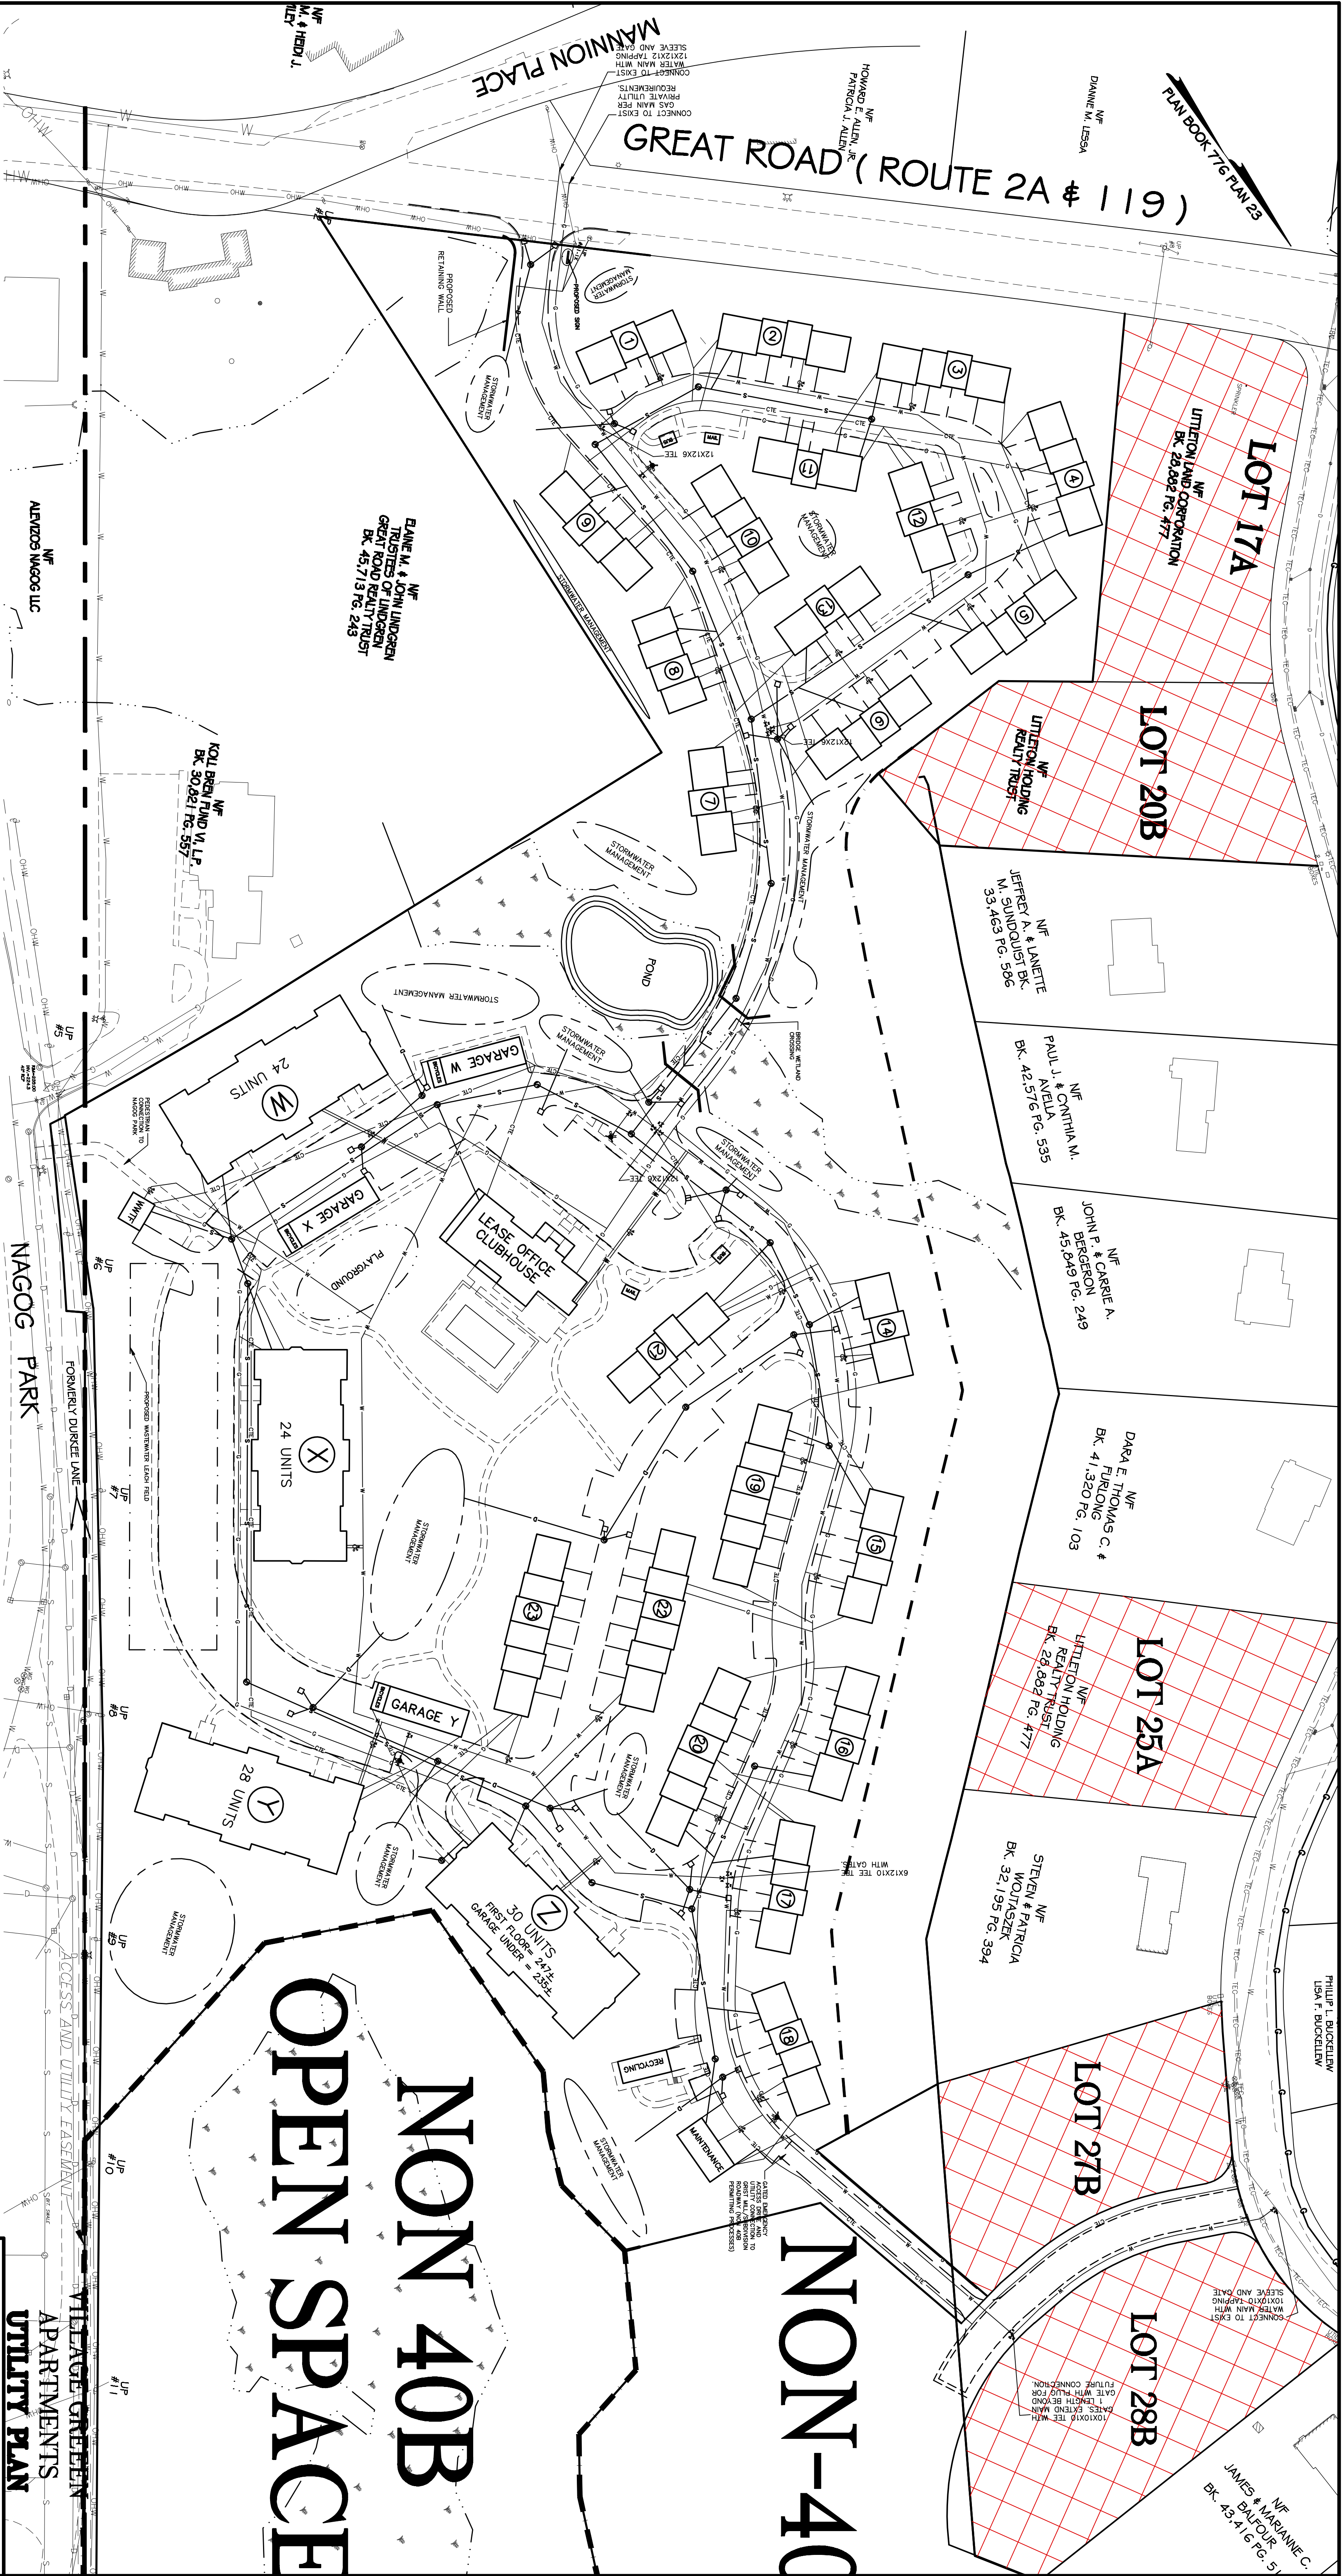

NON-40B OPEN SPACE

VILLAGES AT GREEN APARTMENTS UTILITY PLAN

FIFTEEN GREAT
ROAD II LLC

Places Associates, Inc.

Civil Engineering, Surveying

510 KING STREET, SUITE 9
LITTLETON, MA 01460
978.486.0334 Fax
978.486.0447

PROJECT No.: 11-6303 PLAN No. GP-7

SCALE: 1"=100' DATE: JULY 2011

REVISIONS:
2-16-12 GENERAL REVISION

NOTES:
1. PLAN IS THE COMPILATION OF INFORMATION FROM VARIOUS SOURCES INCLUDING RECORD DEEDS, AERIAL TOPOGRAPHY, WETLANDS DELINEATIONS BY OXBOW ASSOCIATES AND LIMITED ON THE GROUND SURVEY BY PLACES ASSOCIATES, INC.
2. REFER TO SHEET GP-2 FOR ADDITIONAL NOTES.
3. REFER TO UTILITY PLANS FOR CONCEPTUAL DRAINAGE LAYOUT.

PERMIT SET

NOT FOR CONSTRUCTION

