


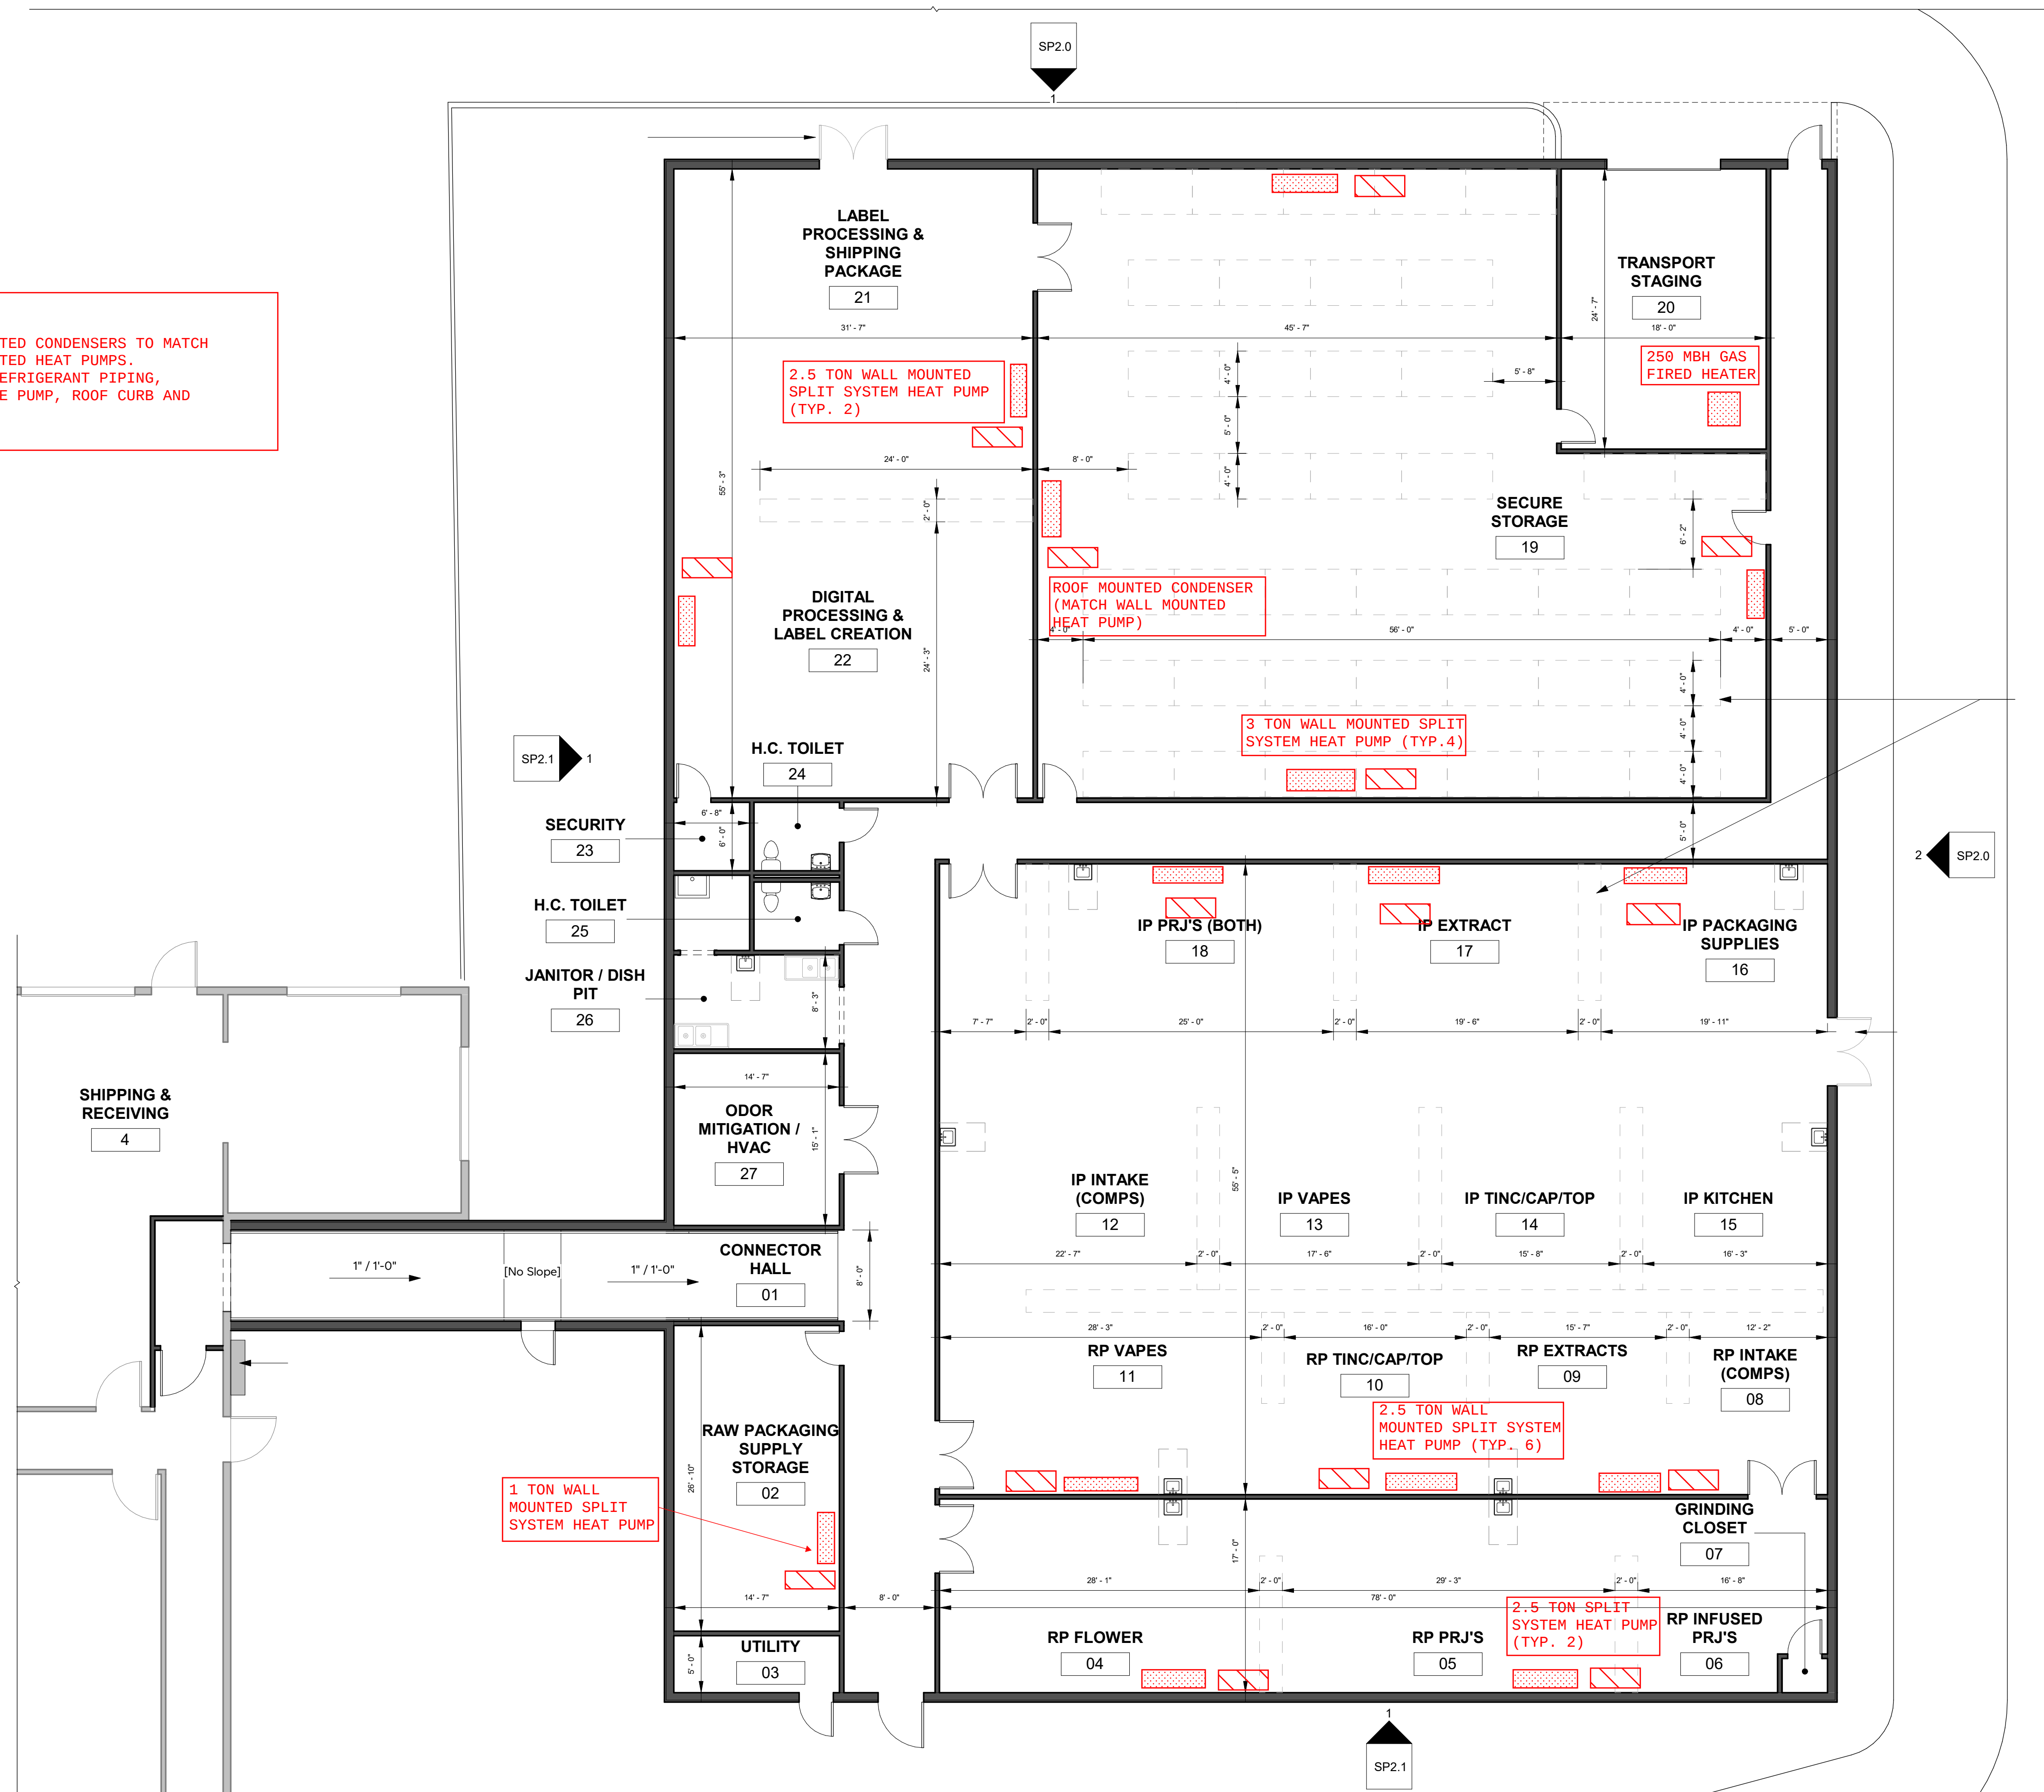

234 TAYLOR STREET, LITTLETON, MA

# SMA LITTLETON EXPANSION

PROJ. NO. 1901-10  
DATE: 01/16/2024  
DRAWN BY:

## PROPOSED HVAC LAYOUT

